

210223 City Mtg

EMERGENCY EGRESS DIAGRAM

CALDWELL
ASSOCIATES | ARCHITECTS

116 N TARRAGONA STREET, PENSACOLA, FL 32502
(850) 432 9500 | CALDWELL-ASSOC.COM

License No: AA26000721 | License No: 180000995

PROJECT ISSUES:	
CONCEPT PLANS	06.19.2020
SCHEMATIC DESIGN	07.14.2020
SCHEMATIC DESIGN 2	08.19.2020
SCHEMATIC DESIGN 3	08.28.2020
SCHEMATIC DESIGN 4	09.11.2020
SCHEMATIC DESIGN 5	02.03.2021
DESIGN DEVELOPMENT	02.17.2021

PROJECT TEAM:	
CIVIL	REBOL BATTLE & ASSOCIATES
STRUCTURAL	LYD ENGINEERING, INC.
ARCHITECTURAL	CALDWELL ASSOC. ARCHITECTS
FIRE PROTECTION	W3 ENGINEERING
PLUMBING, MECHANICAL	W3 ENGINEERING
ELECTRICAL	W3 ENGINEERING
LANDSCAPE	TBD
MOISTURE CONSULTANT	TBD
ACOUSTICAL CONSULTANT	TBD
POOL CONSULTANT	TBD

PROJECT:
**RED FEATHER
TOWNHOUSES**

**150 S BAYLEN STREET
(CORNER OF BAYLEN &
INTENDENCIA)**

**-PRELIMINARY-
NOT FOR
CONSTRUCTION**

 

PROJECT NO. : 20021
SHEET TITLE:
OVERALL SITE

SHEET NUMBER:
AS001
DESIGN DEVELOPMENT

POST OFFICE PARKING LOT

BLAB TV PARKING LOT

Keep
Free
Access
NO LOCK
on their
side

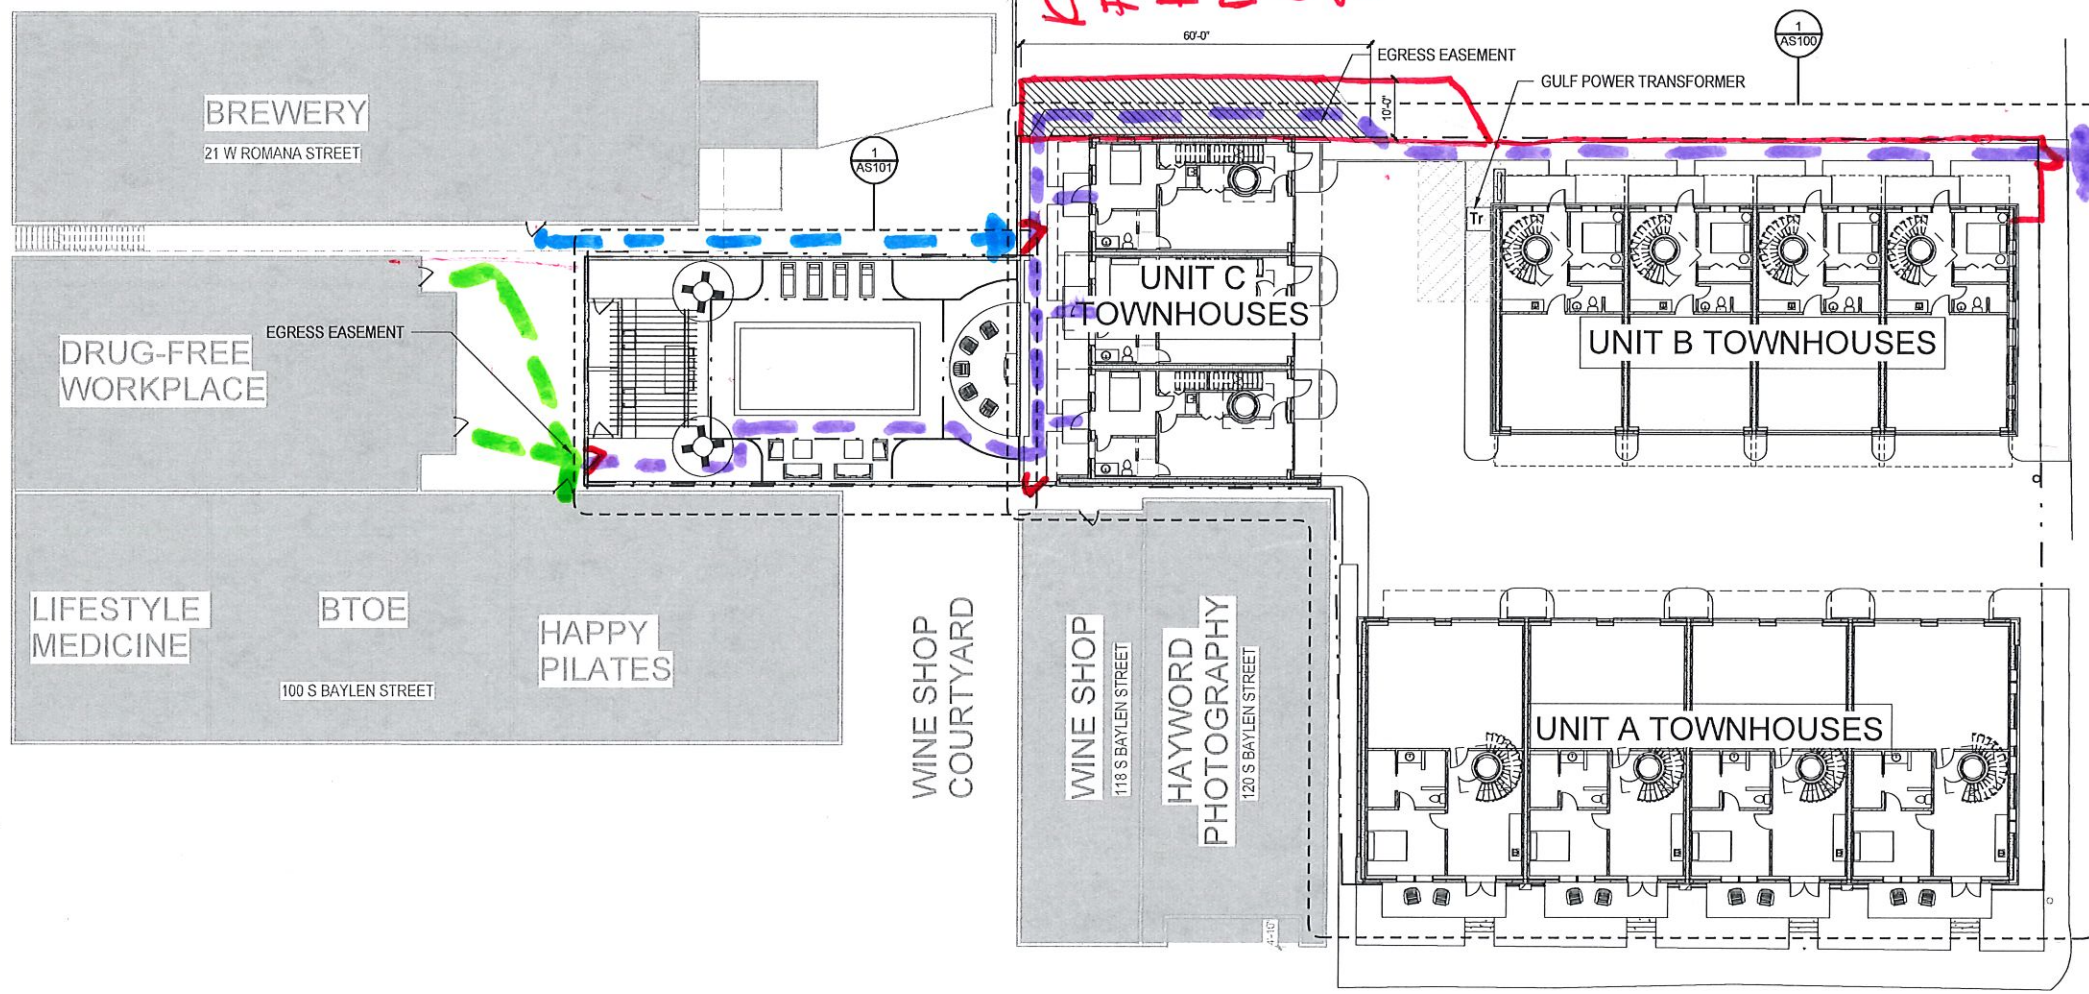

1
AS001

OVERALL SITE PLAN

1/16" = 1'-0"

"FOR REFERENCE ONLY"

16' 8' 0' 16' 32'
DO NOT SCALE DRAWINGS