

TYLER MASTER RENOVATION / ADDITION

4532 Menewa Path, Pensacola FL. 32506

BANKS



CONSTRUCTION
(850)572-4267

TABLE OF CONTENTS

ARCHITECTURAL SHEETS

- SHEET 1 OF 5: COVER SHEET
- SHEET 2 OF 5: PROPOSED SITE PLAN
- SHEET 3 OF 5: PROPOSED FRONT & RIGHT ELEVATION
- SHEET 4 OF 5: PROPOSED FLOOR PLAN
- SHEET 5 OF 5: PROPOSED ELECTRICAL PLAN

SQUARE FOOTAGE



- EXISTING BASE - 2,185
- EXISTING GARAGE - 483
- EXISTING OPEN FINISHED PORCH - 25
- EXISTING SUNROOM - 406

EXISTING TOTAL SQUARE FOOTAGE - 3,099

PROPOSED ADDITION - 351
PROPOSED TOTAL SQUARE FOOTAGE - 3,450

SCOPE OF WORK

THE CLIENT IS LOOKING TO RENOVATE & EXPAND THE EXISTING MASTER BEDROOM. AN ADDITION WILL BE PLACED OFF THE REAR OF THE HOME & THE EXISTING SUNROOM WILL TIE INTO THE ADDITION. THE EXISTING MASTER BATHROOM FIXTURE LOCATIONS WILL MOVE TO ACCOMMODATE THE NEW LAYOUT.

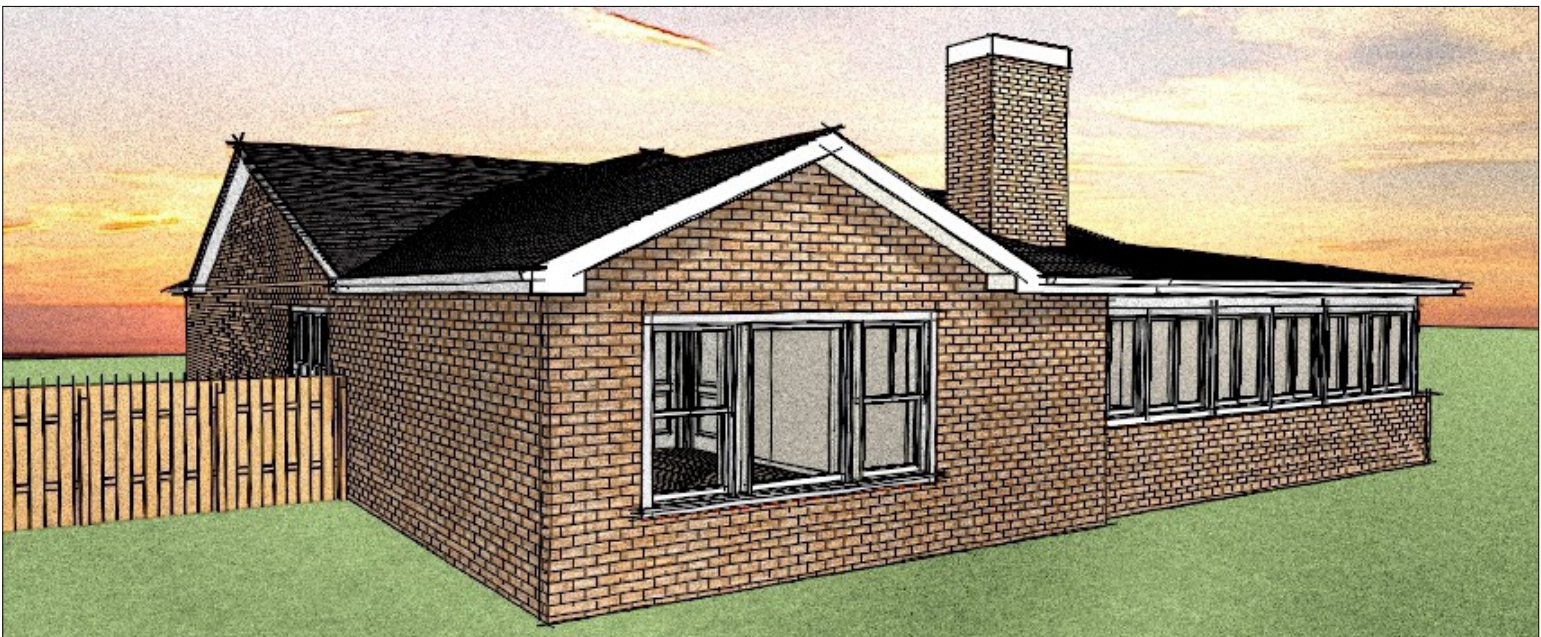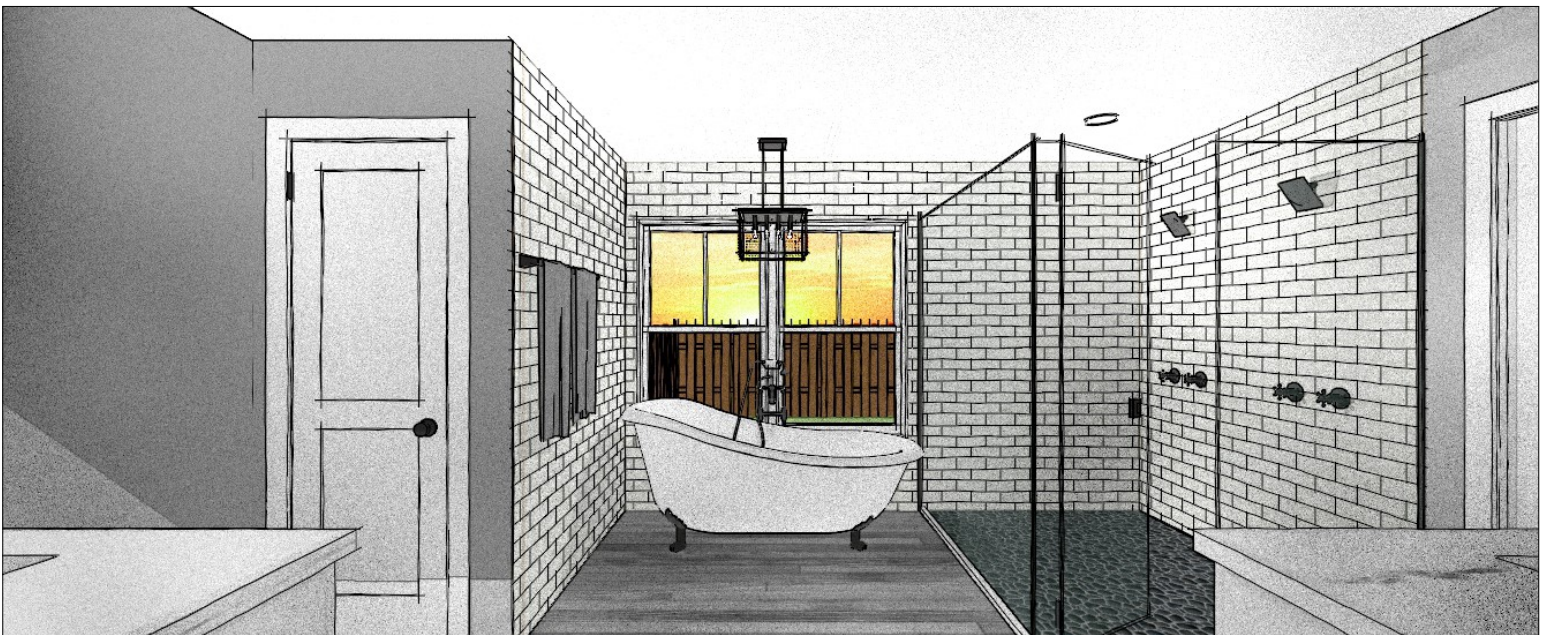

ENGINEERED SHEETS
ARE SIGNED & SEALED

REVISIONS

A
B
C

PROJECT INFORMATION

DESCRIPTION: Tyler Renovation & Addition

NAME:

ADDRESS: 4532 Menewa Path, Pensacola, FL. 32506

**REFLECTIONS Home Designs
& CAD Services**

Email: timdanieljr83@gmail.com / Phone: (850)-417-5332

facebook.com/ReflectionsHomeDesigns
twitter.com/HomeDesignsCAD
instagram.com/HomeDesignsCAD

DATE: 07/23/2020

SCALE: -


SHEET: ARCHITECTURAL
1 OF 5

13' - 6" RIDGE HEIGHT (HIP)
12' - 2 1/2" RIDGE HEIGHT (GABLE)


8' - 0" CEILING HEIGHT

2 : 12 CATHEDRAL CEILING (MASTER BEDROOM)

FINISHED FLOOR ELEVATION

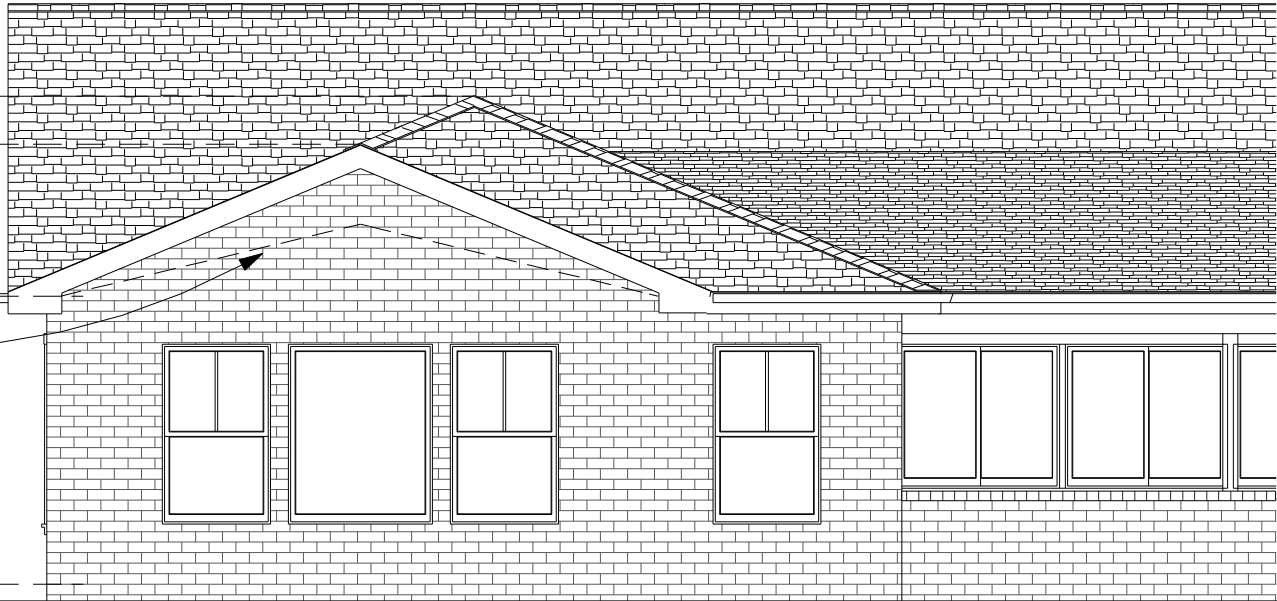

PROPOSED REAR ELEVATION
SCALE: 3/16" = 1' - 0"

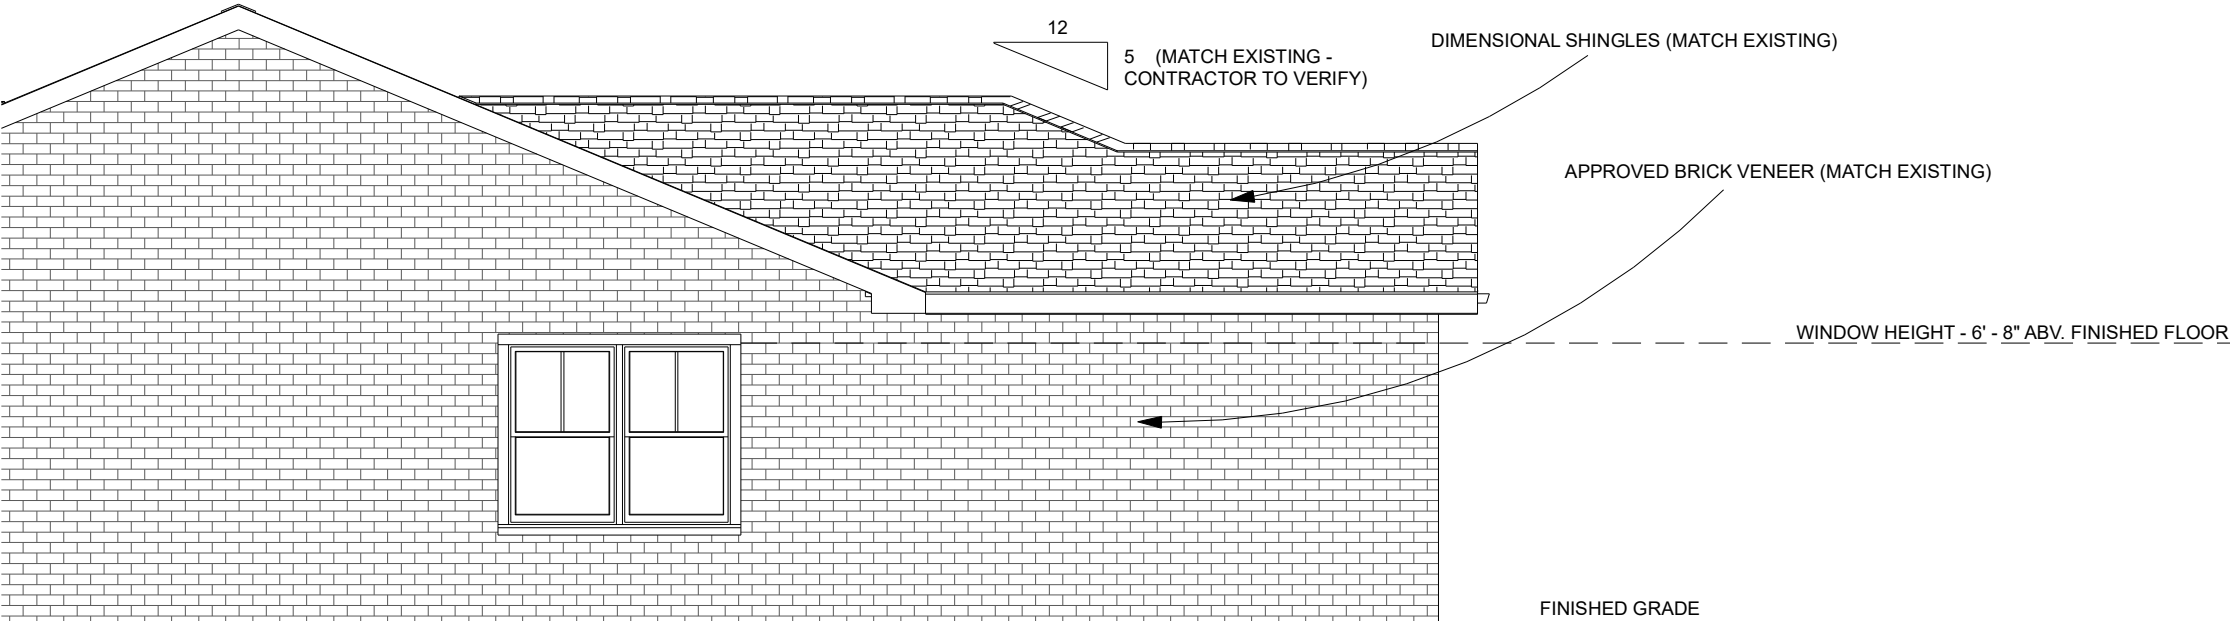

PROPOSED RIGHT ELEVATION
SCALE: 3/16" = 1' - 0"

REVISIONS

A
B
C

PROJECT INFORMATION

DESCRIPTION: Tyler Renovation & Addition

NAME:

ADDRESS: 4532 Menewa Path, Pensacola, FL 32506

**REFLECTIONS Home Designs
& CAD Services**

Email: timdanieljr83@gmail.com / Phone: (850)-417-5332


facebook.com/ReflectionsHomeDesigns
twitter.com/HomeDesignsCAD
instagram.com/HomeDesignsCAD

DATE: 07/23/2020

SCALE: -

SHEET: ARCHITECTURAL
3 OF 5

ENGINEERED SHEETS
ARE SIGNED & SEALED

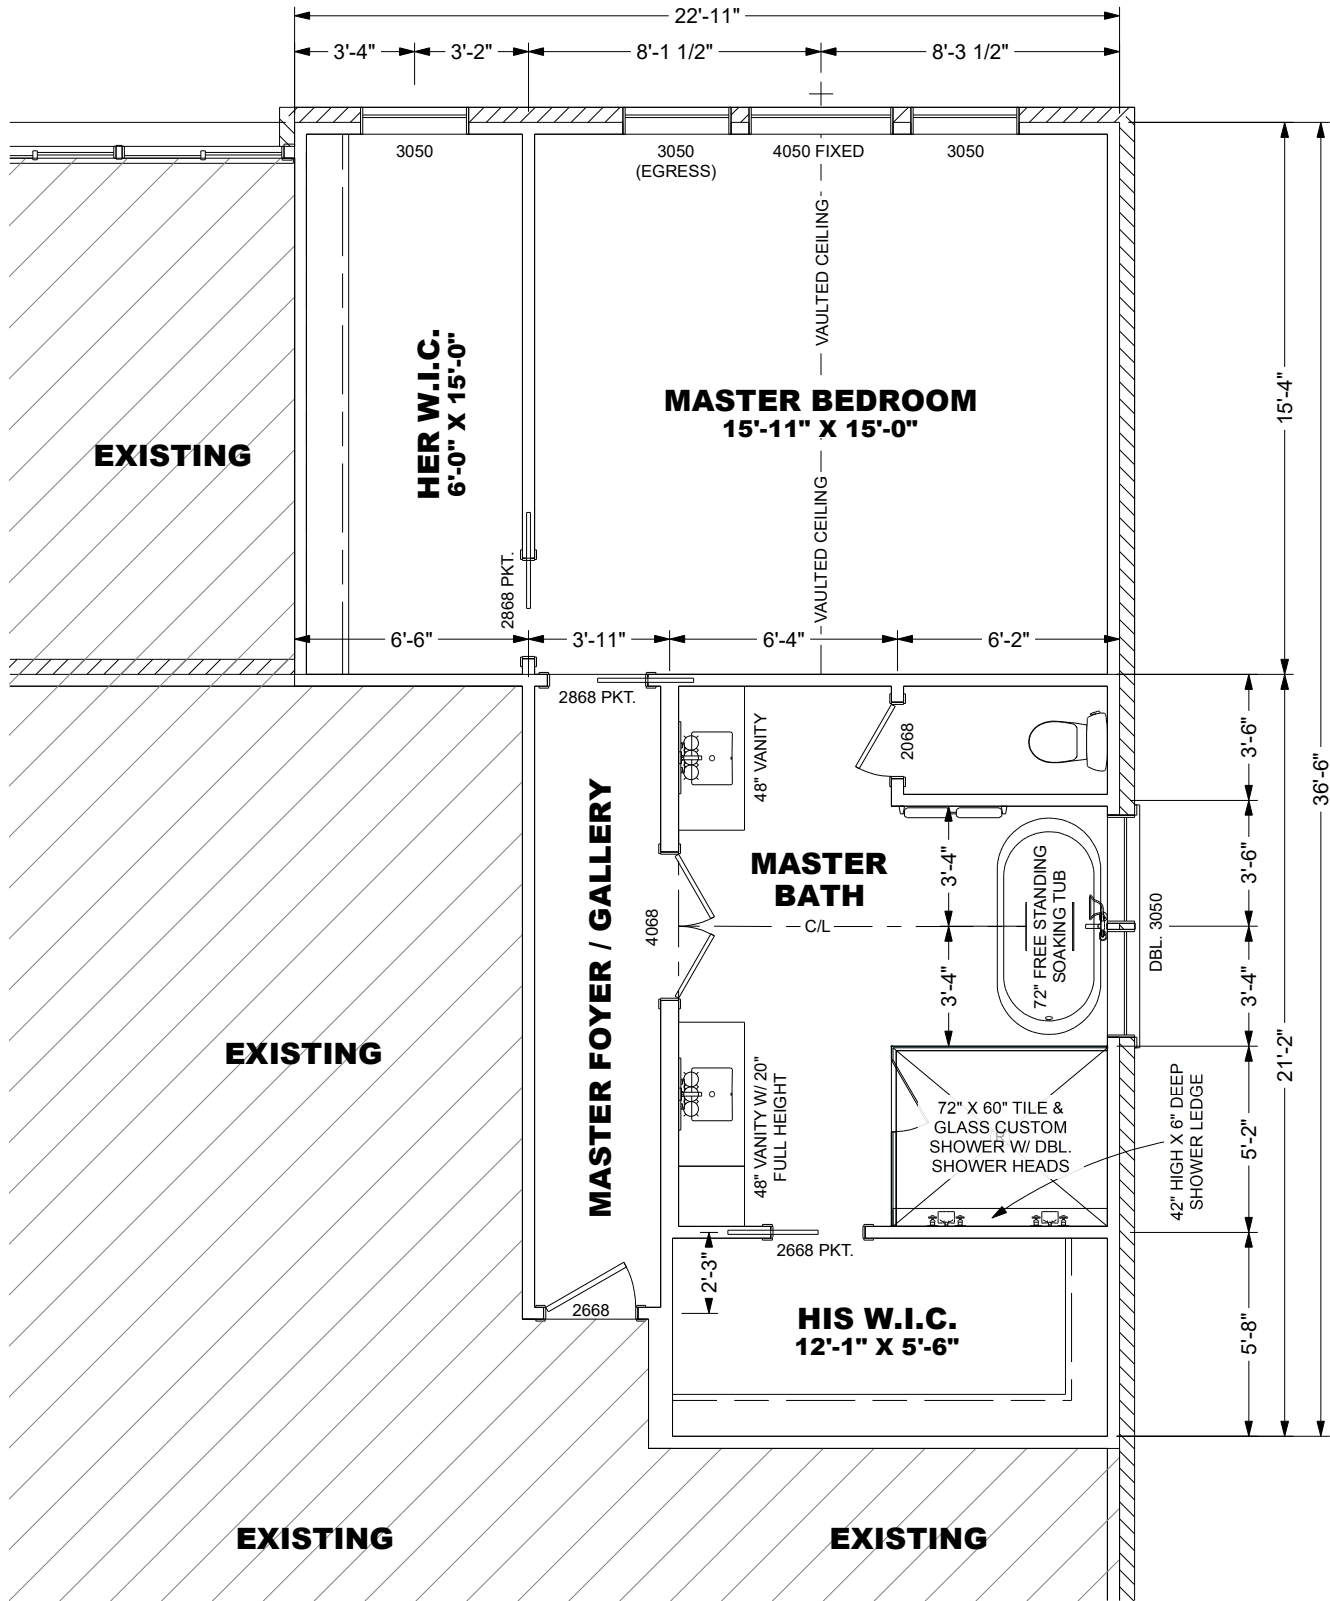

PROPOSED FLOOR PLAN
SCALE: 3/16" = 1' - 0"

ENGINEERED SHEETS
ARE SIGNED & SEALED

REVISIONS	
A	
B	
C	

PROJECT INFORMATION	
DESCRIPTION:	Tyler Renovation & Addition
NAME:	
ADDRESS:	4532 Menewa Path, Pensacola, FL 32506

BANKS



CONSTRUCTION
(850)572-4267

**REFLECTIONS Home Designs
& CAD Services**

Email: timdanieljr83@gmail.com / Phone: (850)-417-5332

facebook.com/ReflectionsHomeDesigns
twitter.com/HomeDesignsCAD
instagram.com/HomeDesignsCAD

DATE:	07/23/2020
SCALE:	-
SHEET:	ARCHITECTURAL 4 OF 5